




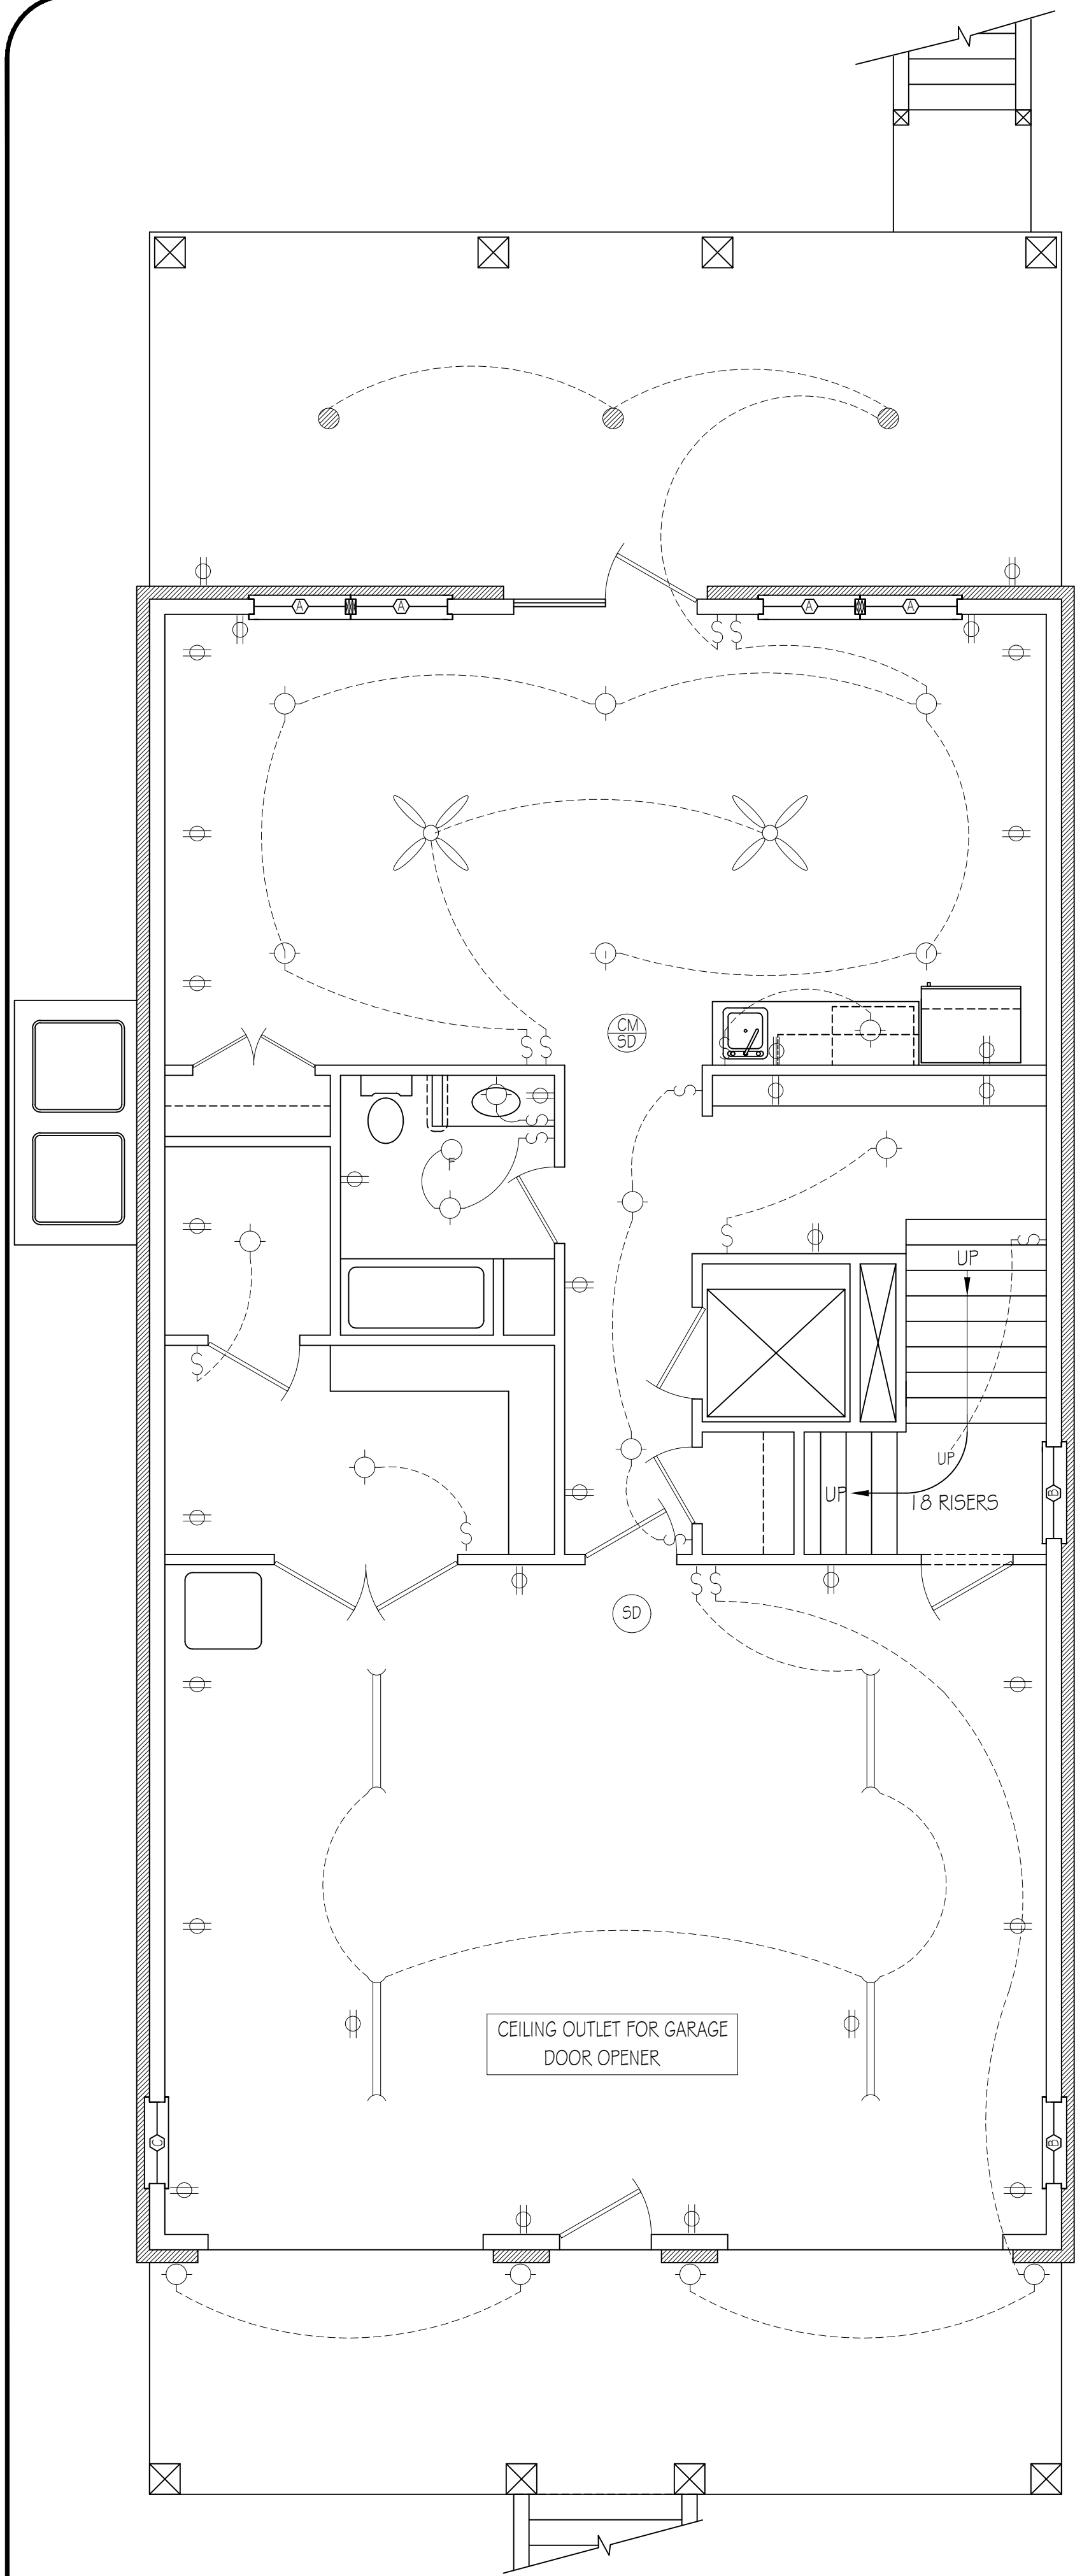

GROUND LEVEL ELECTRICAL
9'-0" CEILING HEIGHT
SCALE: 1/4"=1'-0"

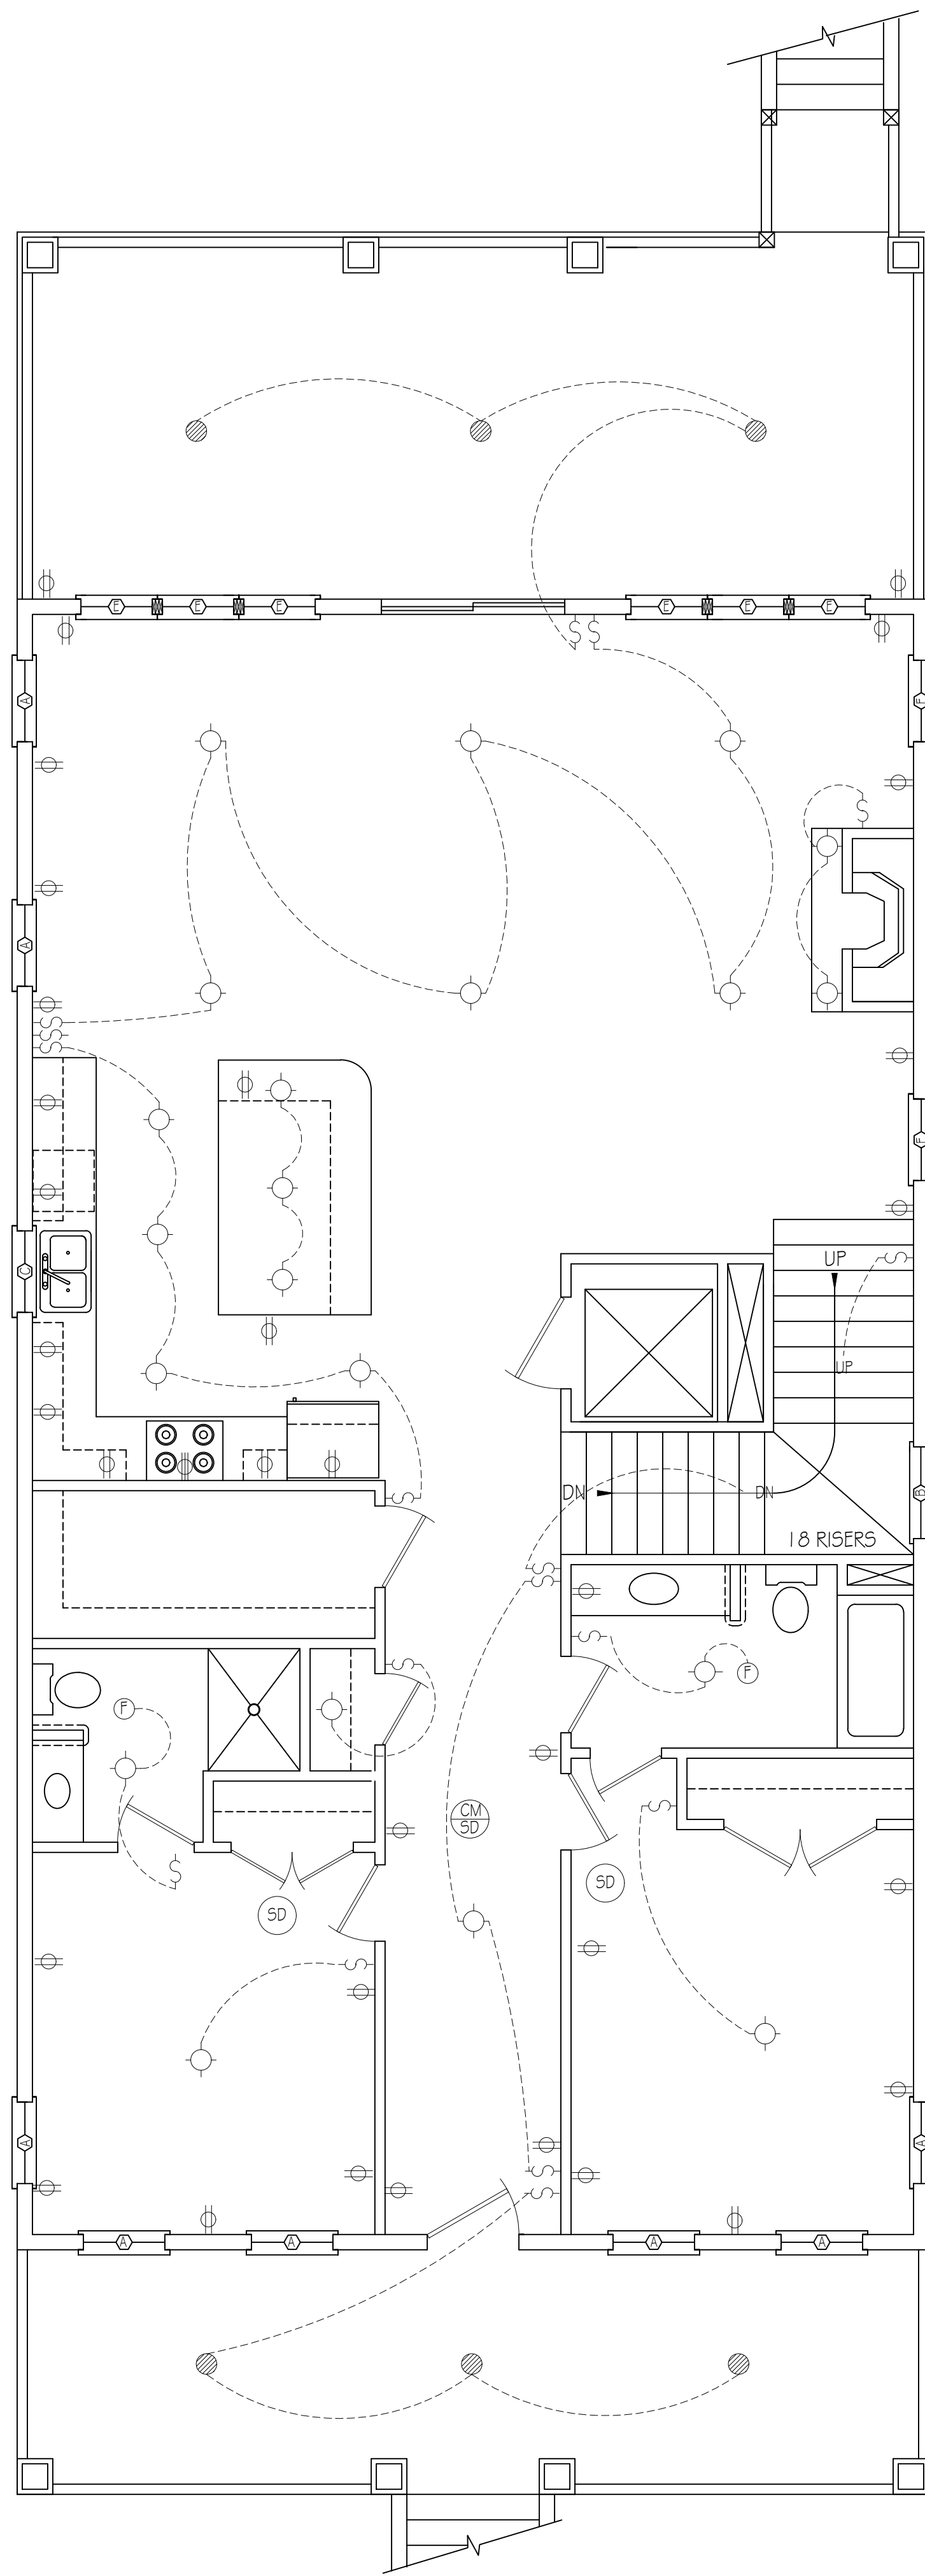

FIRST FLOOR ELECTRICAL
10'-0" CEILING HEIGHT
SCALE: 1/4"=1'-0"

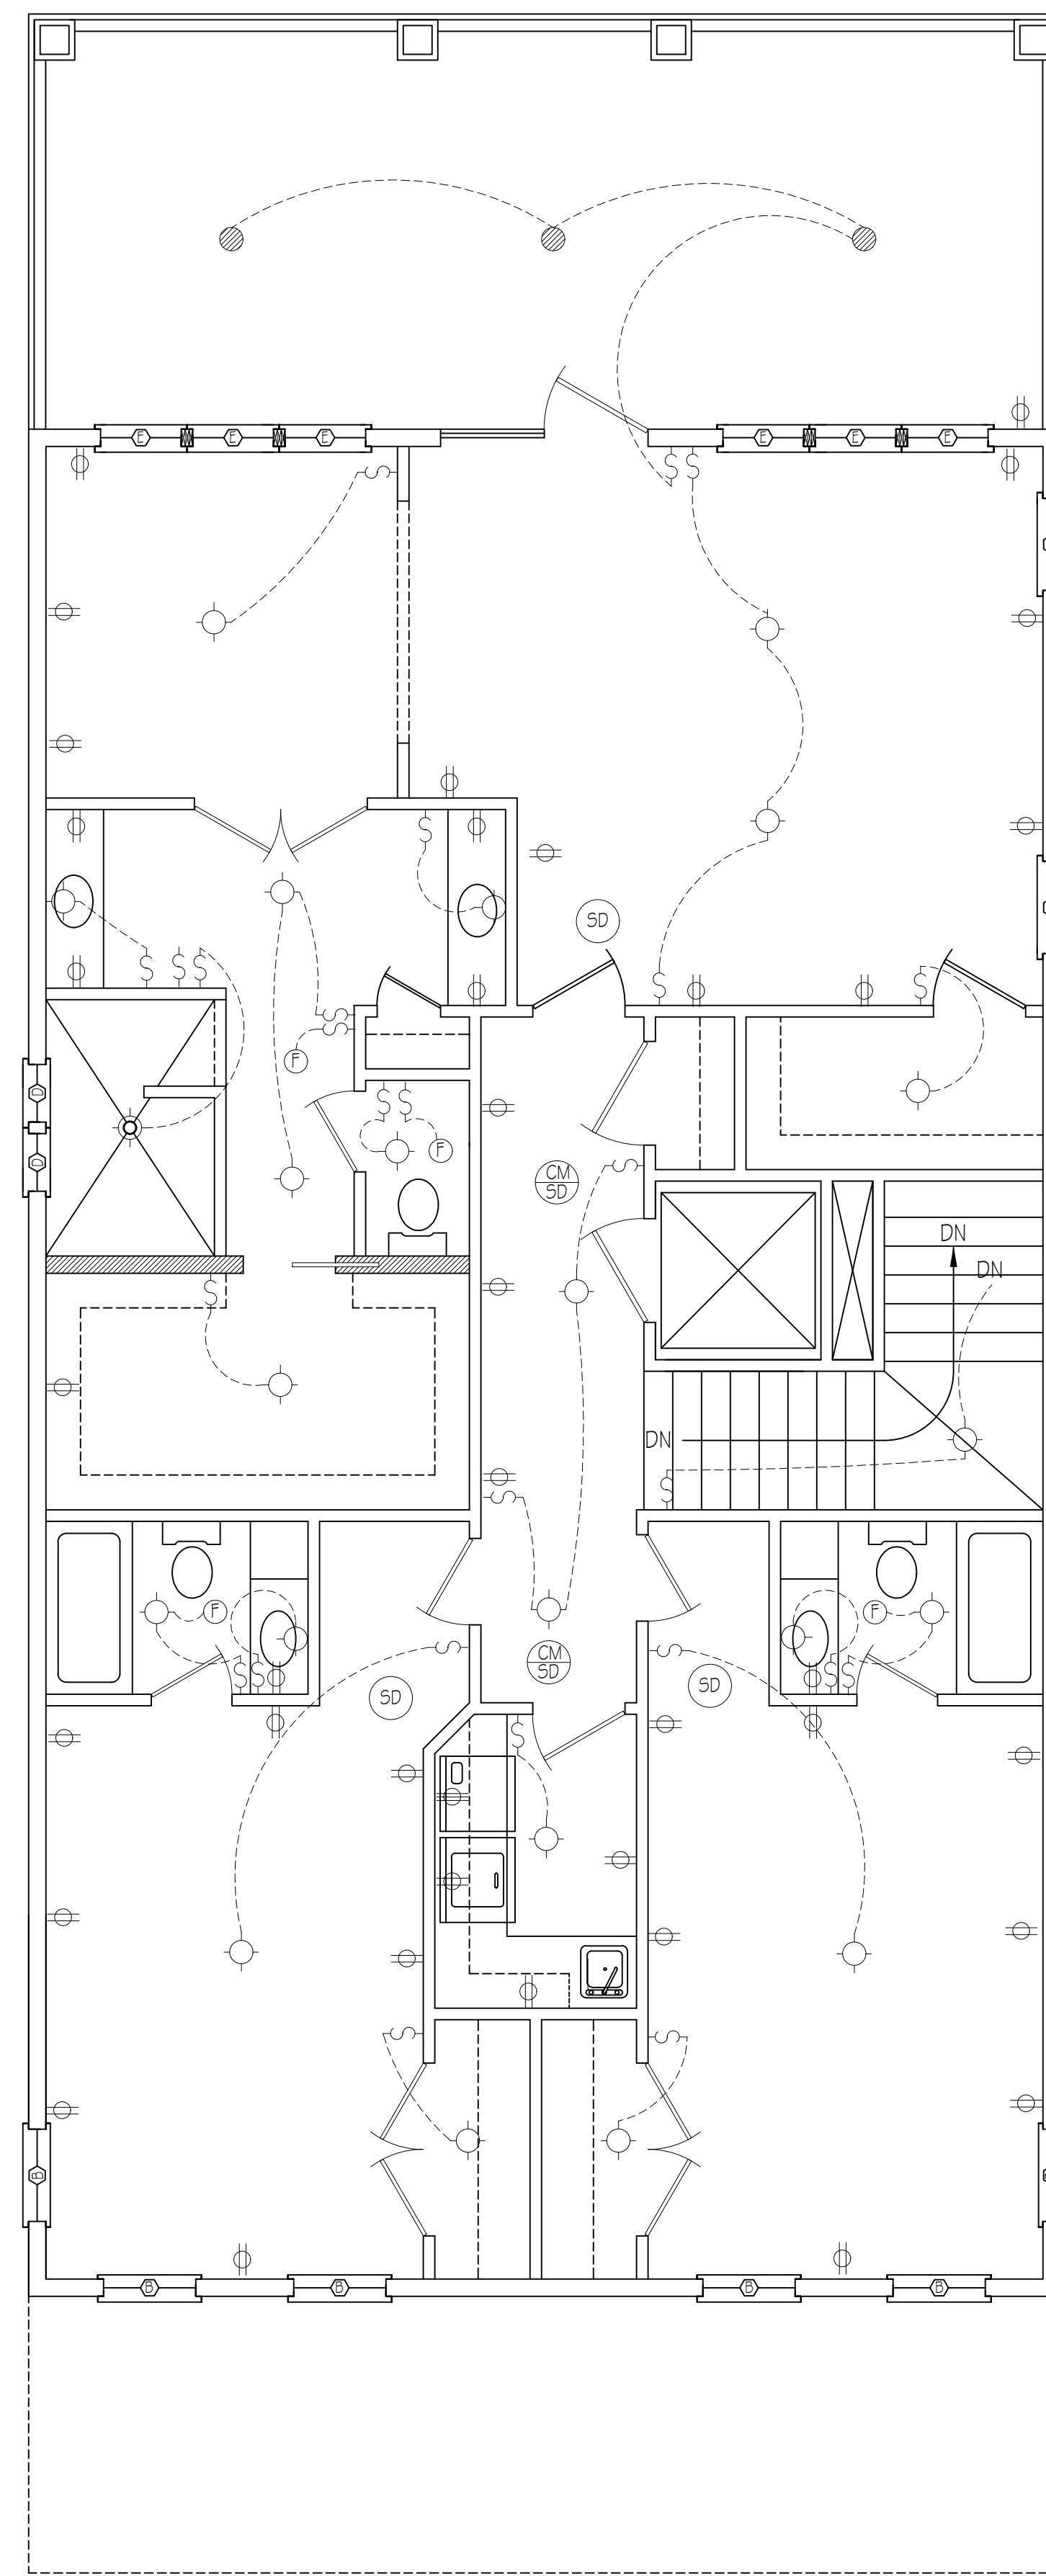

SECOND FLOOR ELECTRICAL
9'-0" CEILING HEIGHT
SCALE: 1/4"=1'-0"

ELECTRICAL LEGEND	
	CAN RECESSED LIGHT
	WALL MOUNTED LIGHT
	CEILING MOUNTED LIGHT
	FAN/LIGHT COMBINATION
	110 VOLT DUPLEX OUTLET
	220 VOLT SERVICE OUTLET
	CARBON MONOXIDE/SMOKE DETECTOR
	SMOKE DETECTOR
	CEILING FAN/LIGHT COMBINATION
	FLUORESCENT LIGHT
	EXTERIOR SPOTLIGHT

DRAWING: ELECTRICAL PLAN

SCALE: 1/4"=1'-0"


DATE=07-22-26

SHEET #6

CLIENT:

REVISIONS:

Turn Key Builders

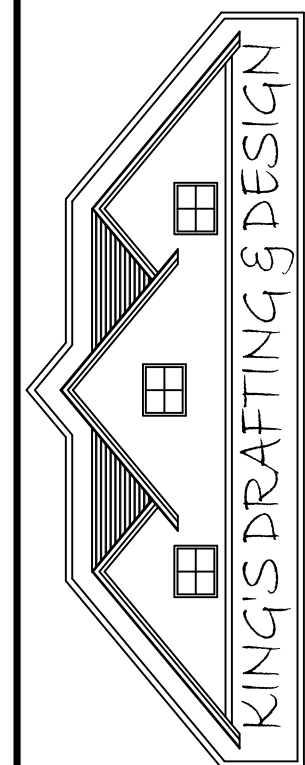

SNOW HILL, NC

252-341-4018

ALL APPLICABLE CODES SHALL BE CONSIDERED AS PART OF THE SPECIFICATIONS FOR THIS BUILDING AND SHALL TAKE PRECEDENCE OVER ANYTHING SHOWN HEREON. IF APPLIED WHERE SAME ARE IN CONFLICT, THE MORE STRINGENT SHALL BE USED IN PREFERENCE TO SAID MEASUREMENTS. CONTRACTOR SHALL VERIFY ALL DIMENSIONS AND SITE CONDITIONS BEFORE BEGINNING WORK.